


X Window Schedule

Mark	Size	Description	Count
1	2'-6" X 3'-9"	2'-6" X 3'-9" Double Hung Window	2

X Door Schedule

Mark	Size	Description	Count
1	5' X 6'-8"	5' Steel Double Doors w/ 6 Lite Inserts	1
2	2'-8" X 6'-8"	32" HINGED DOOR	2

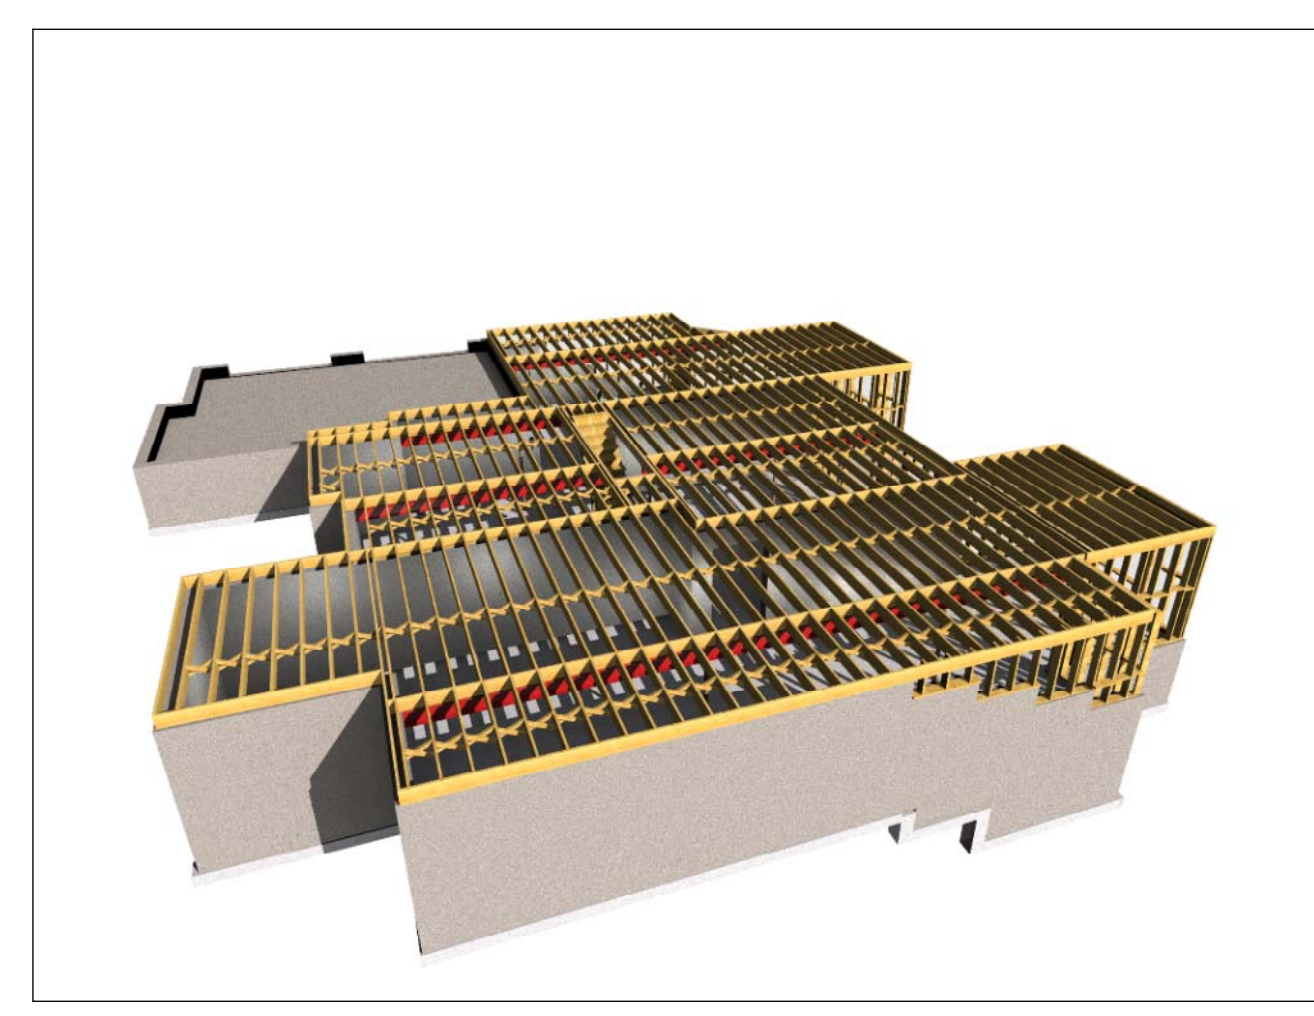

ELECTRICAL LEGEND

	CEILING LIGHT
	POT LIGHT
	120V OUTLET
	SINGLE SWITCH
	DOUBLE SWITCH

FOUNDATION PLAN

SCALE: 1/4" = 1'-0"

General Notes

No.	Revision/Issue	Date

Orientation: _____ Stamp: _____

ALL DRAWINGS ARE THE PROPERTY OF THE DESIGNER AND THEY ARE NOT TO BE REPRODUCED IN WHOLE OR IN PART WITHOUT THE WRITTEN CONSENT OF THE DESIGNER.
CONTRACTOR TO CHECK AND VERIFY ALL DIMENSIONS BEFORE COMMENCING WORK AND TO REPORT ANY DISCREPANCIES TO THE DESIGNER.

Cadsoft
Orlough, ON
1-888-CADSOFT

Project Name and Address:
McFarlin House

Client:
Steve Wise

Drawing: **Foundation Plan**

Scale: 1/4" = 1' - 0" Date: August, 2009

Drawn By: S.J.W.	Sheet:
Checked By:	A-2
Approved By:	